




4 RIDGE / HIP DETAIL
NOT TO SCALE

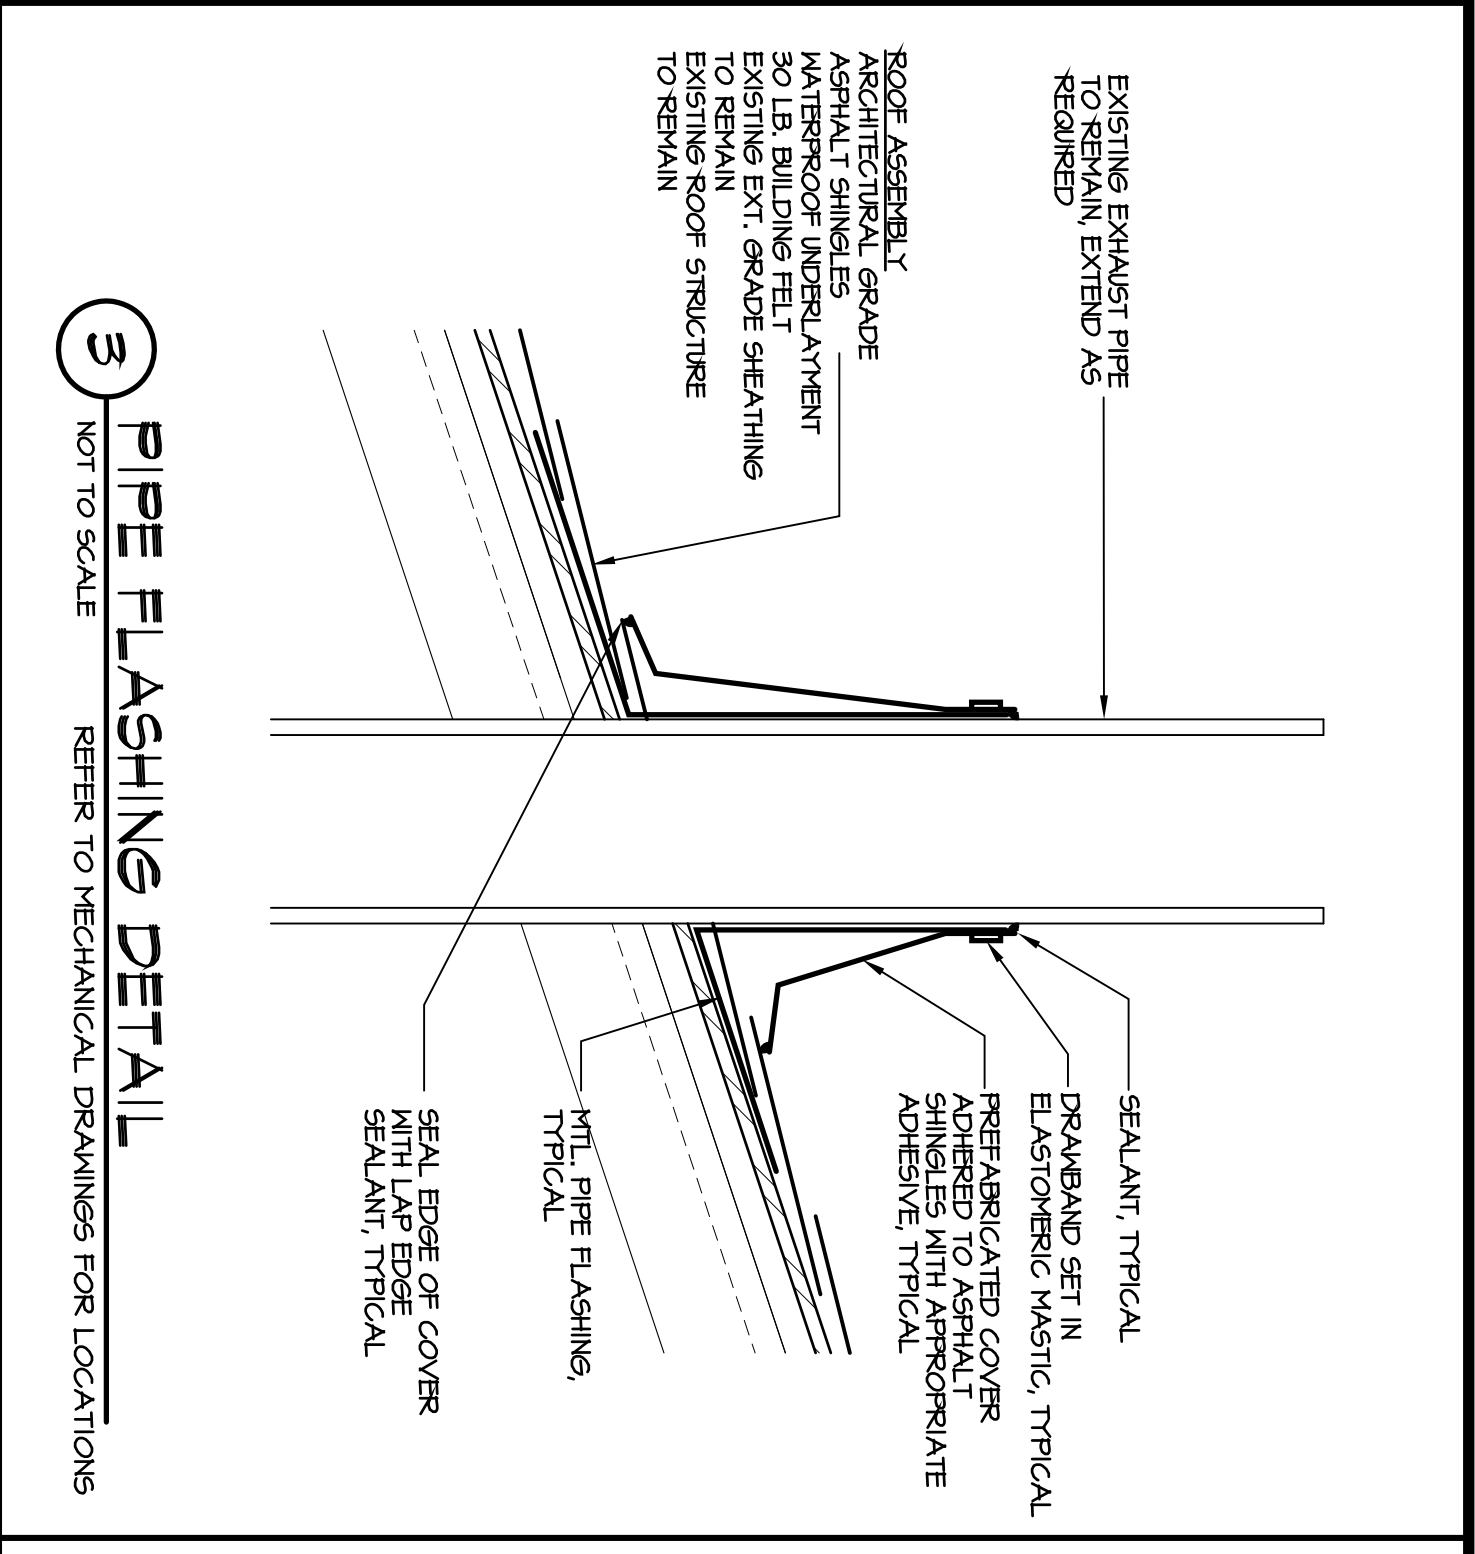


3 PIPE FLASHING DETAIL
NOT TO SCALE REFER TO MECHANICAL DRAINAGES FOR LOCATIONS

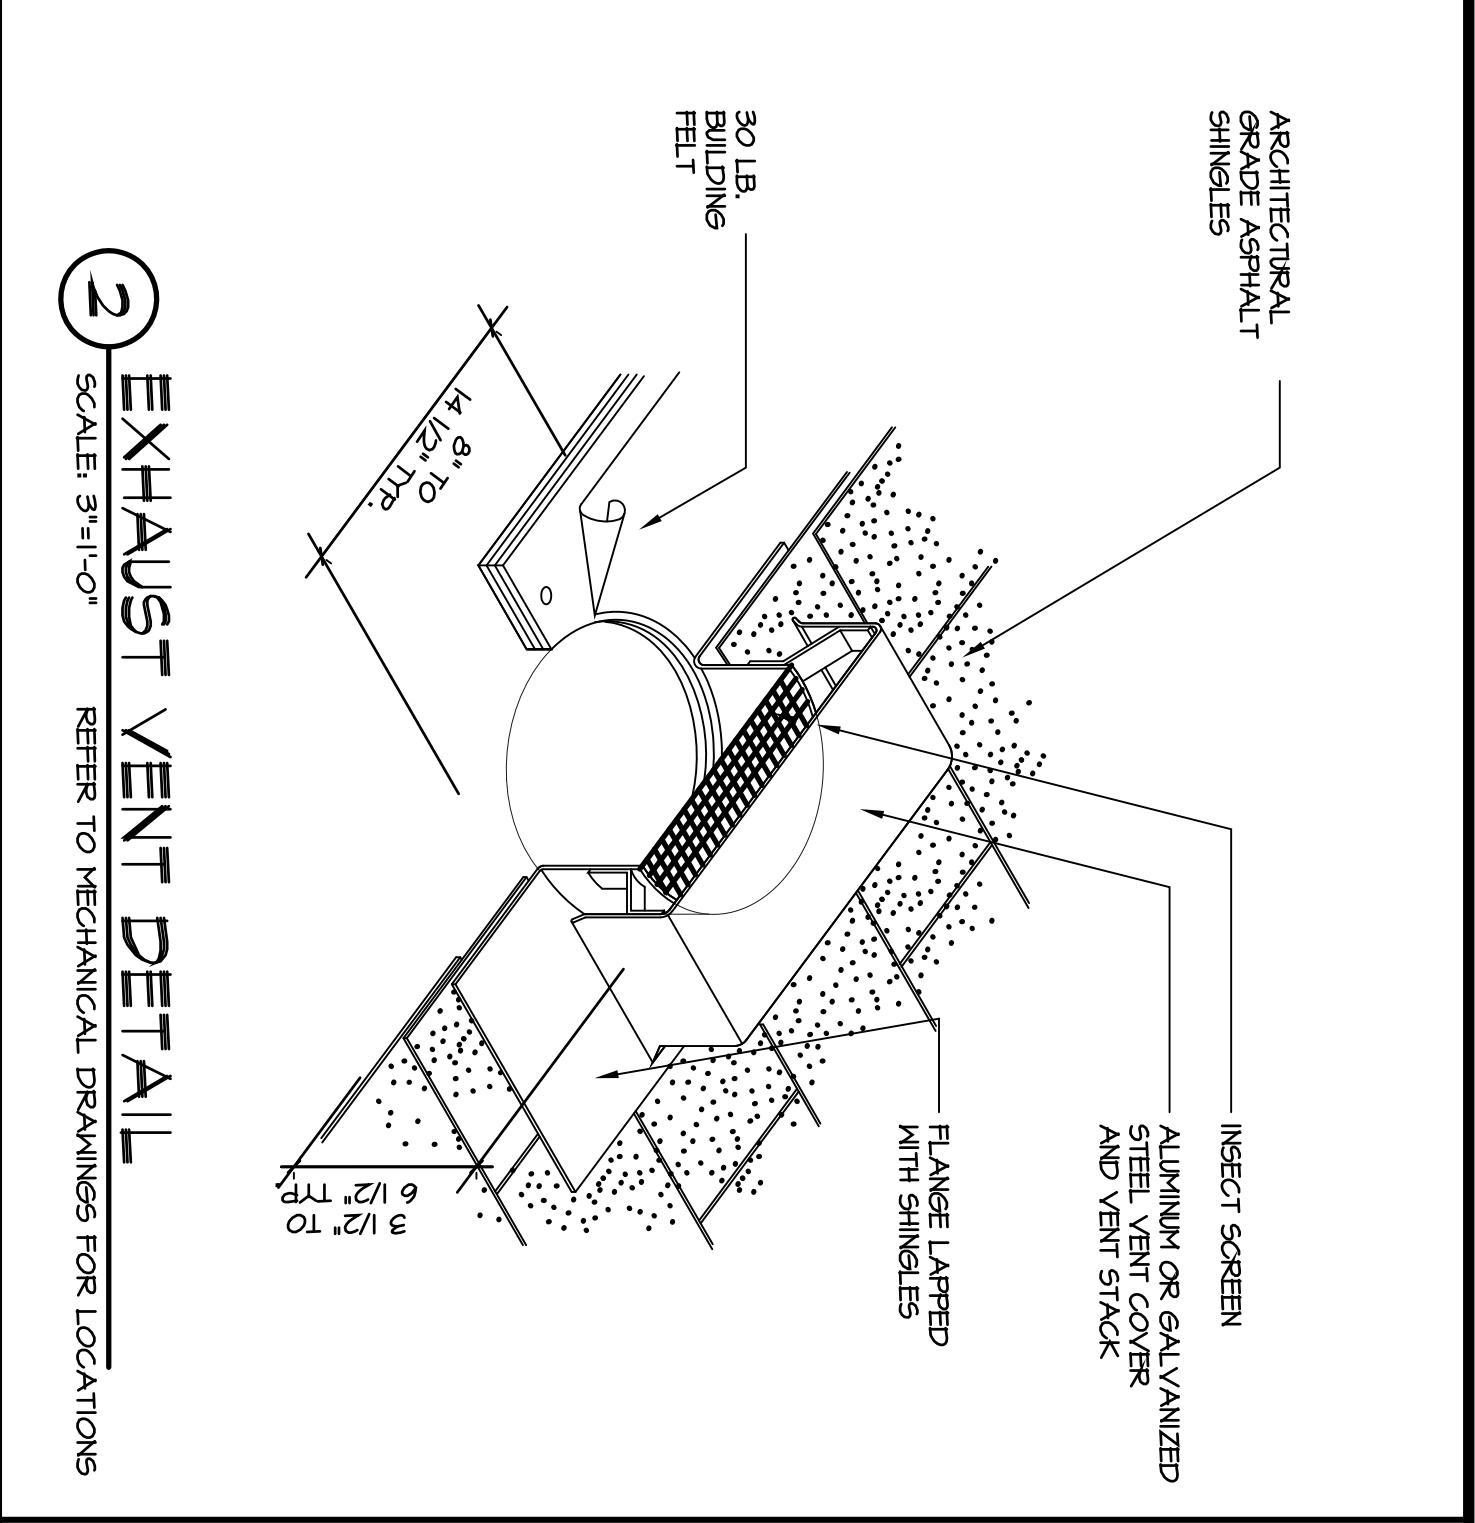


2 EXHAUST VENT DETAIL
SCALE 3/4"=1'-0" REFER TO MECHANICAL DRAINAGES FOR LOCATIONS

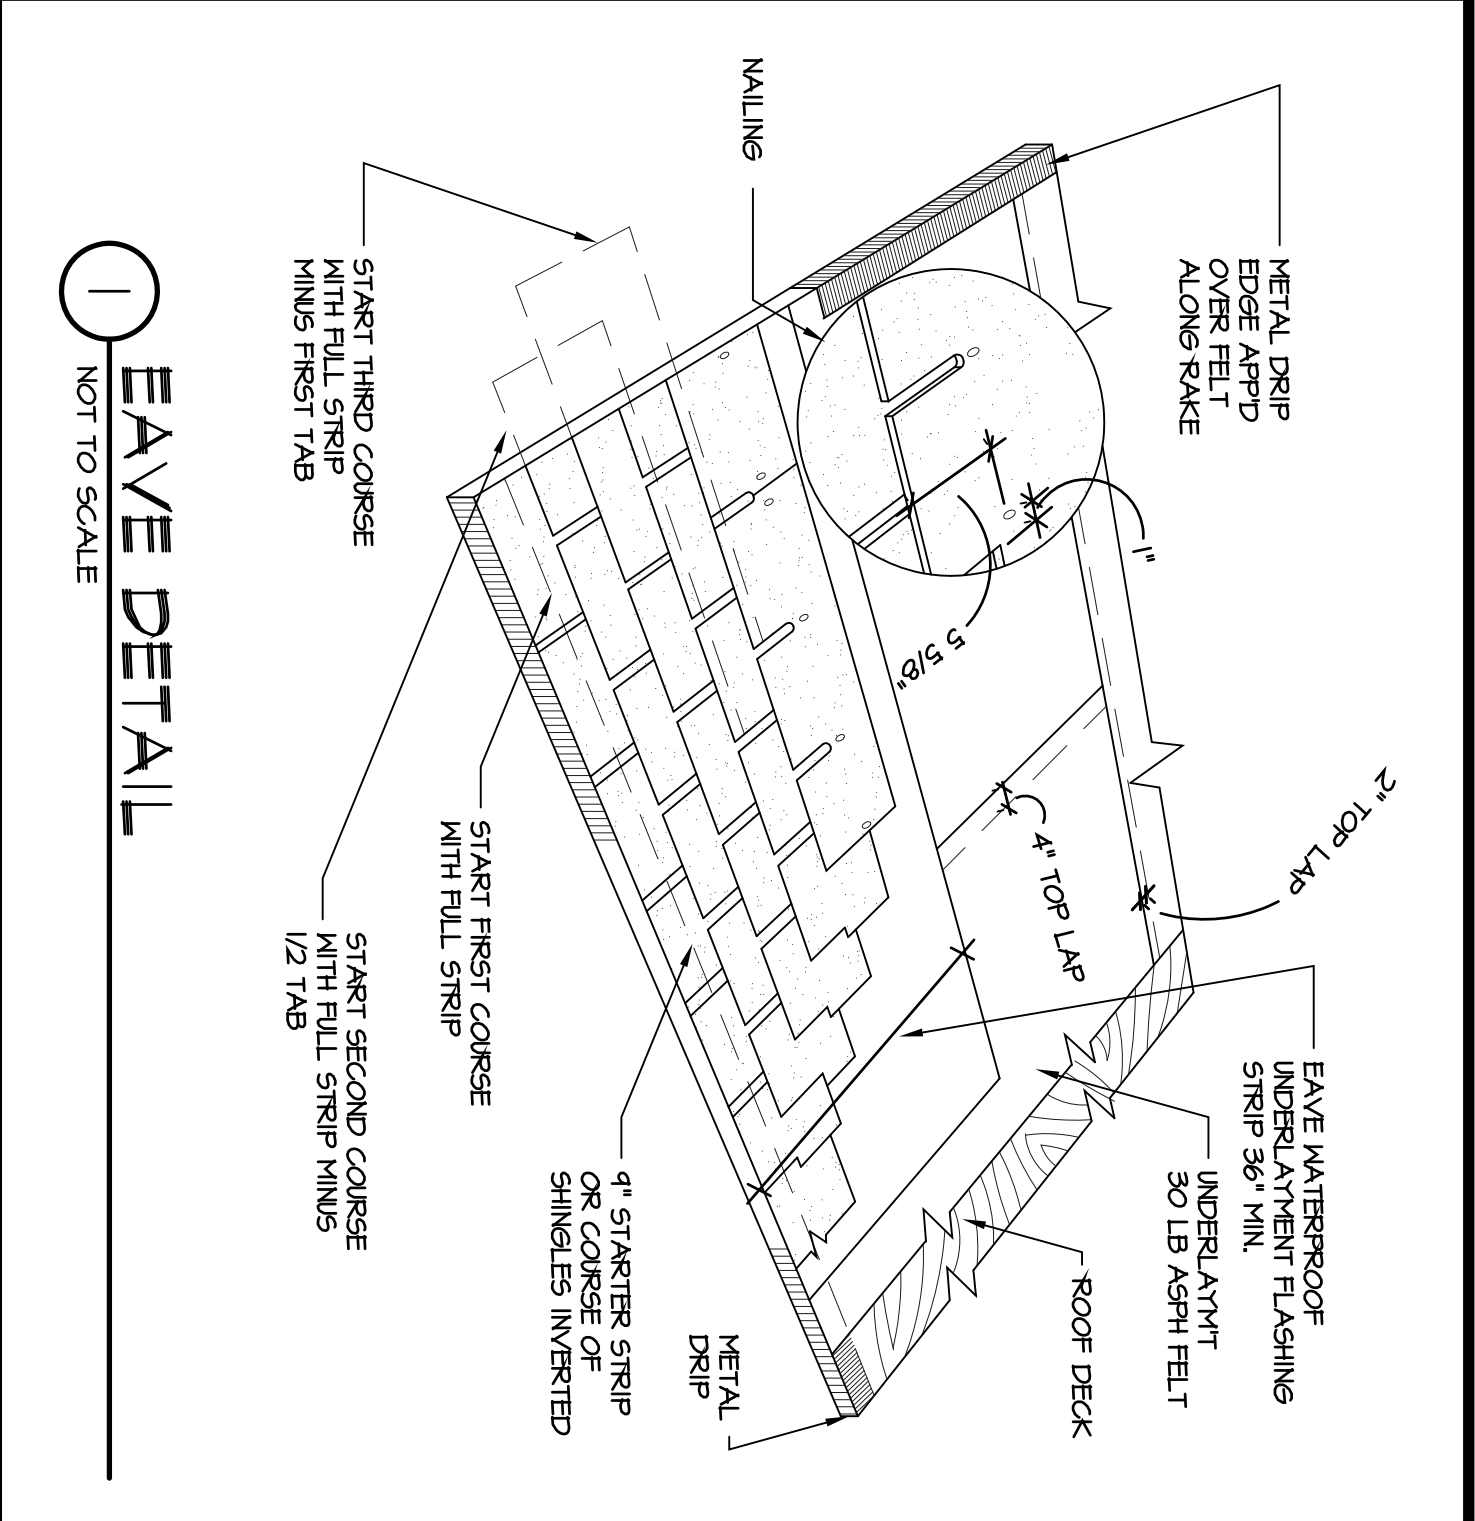

1 EAVE DETAIL
NOT TO SCALE

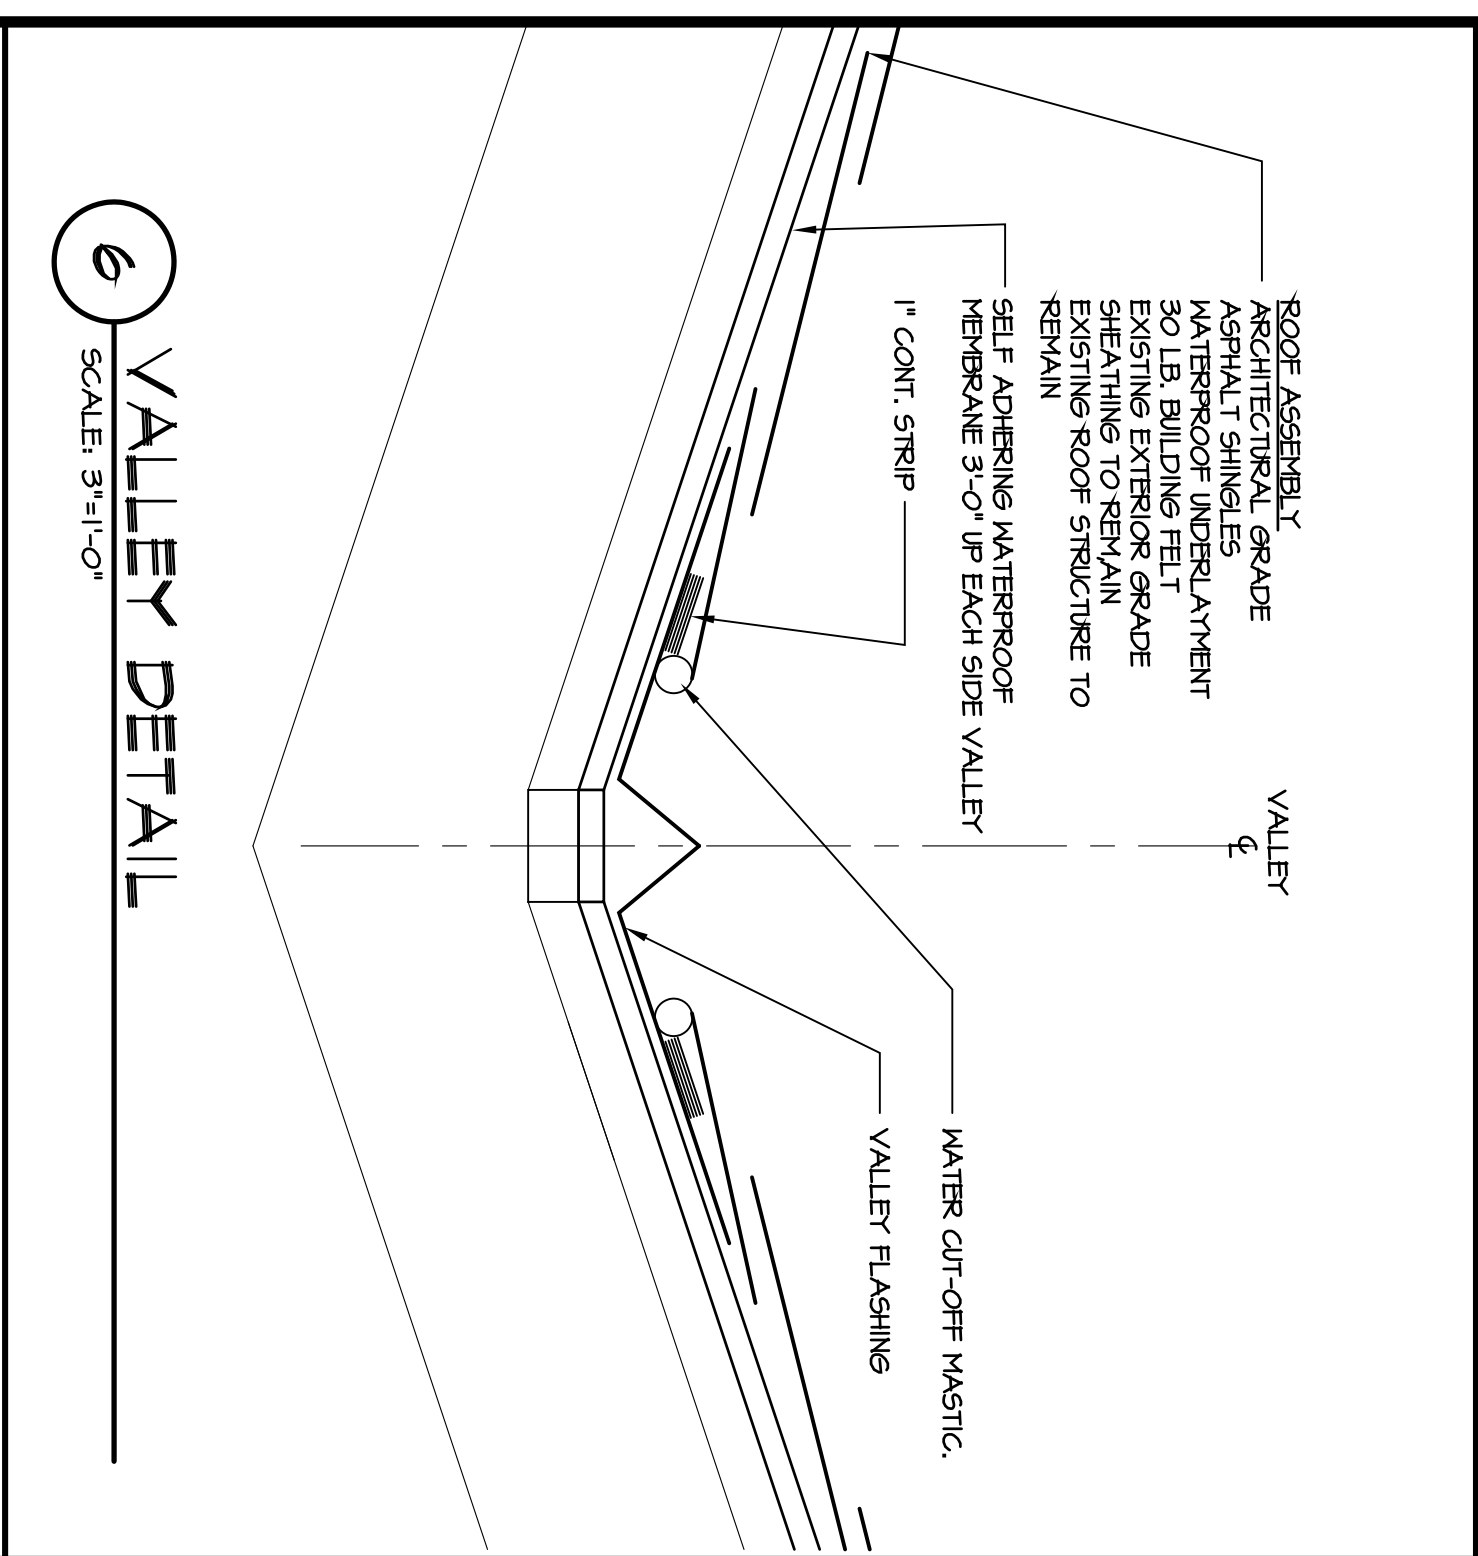


6 VALLEY DETAIL
SCALE 3/4"=1'-0"

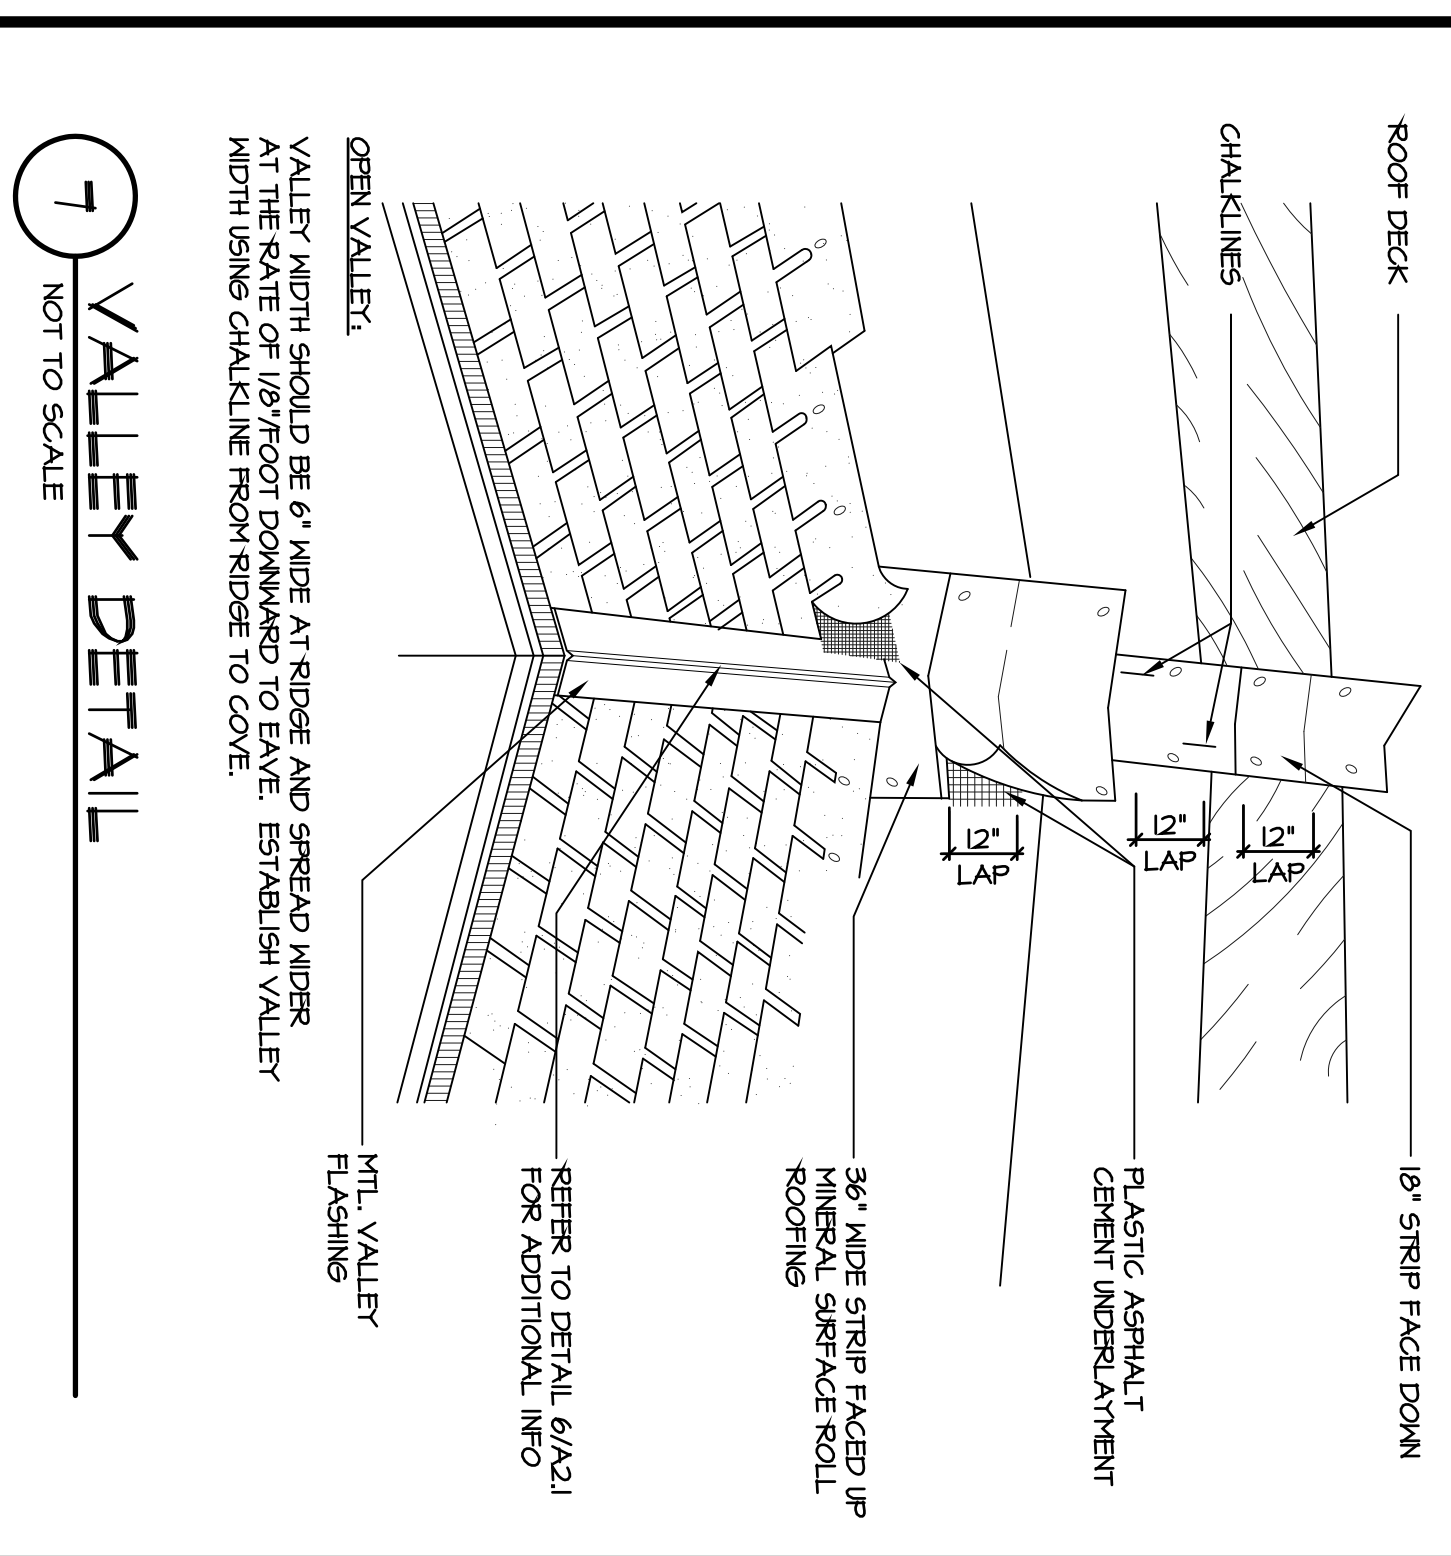

7 VALLEY DETAIL
NOT TO SCALE

ABBREVIATIONS LEGEND

DS	DOWNSPOUT
PV	PLUMBING VENT
EF	NEW EXHAUST FAN
→	DIRECTION OF ROOF SLOPE

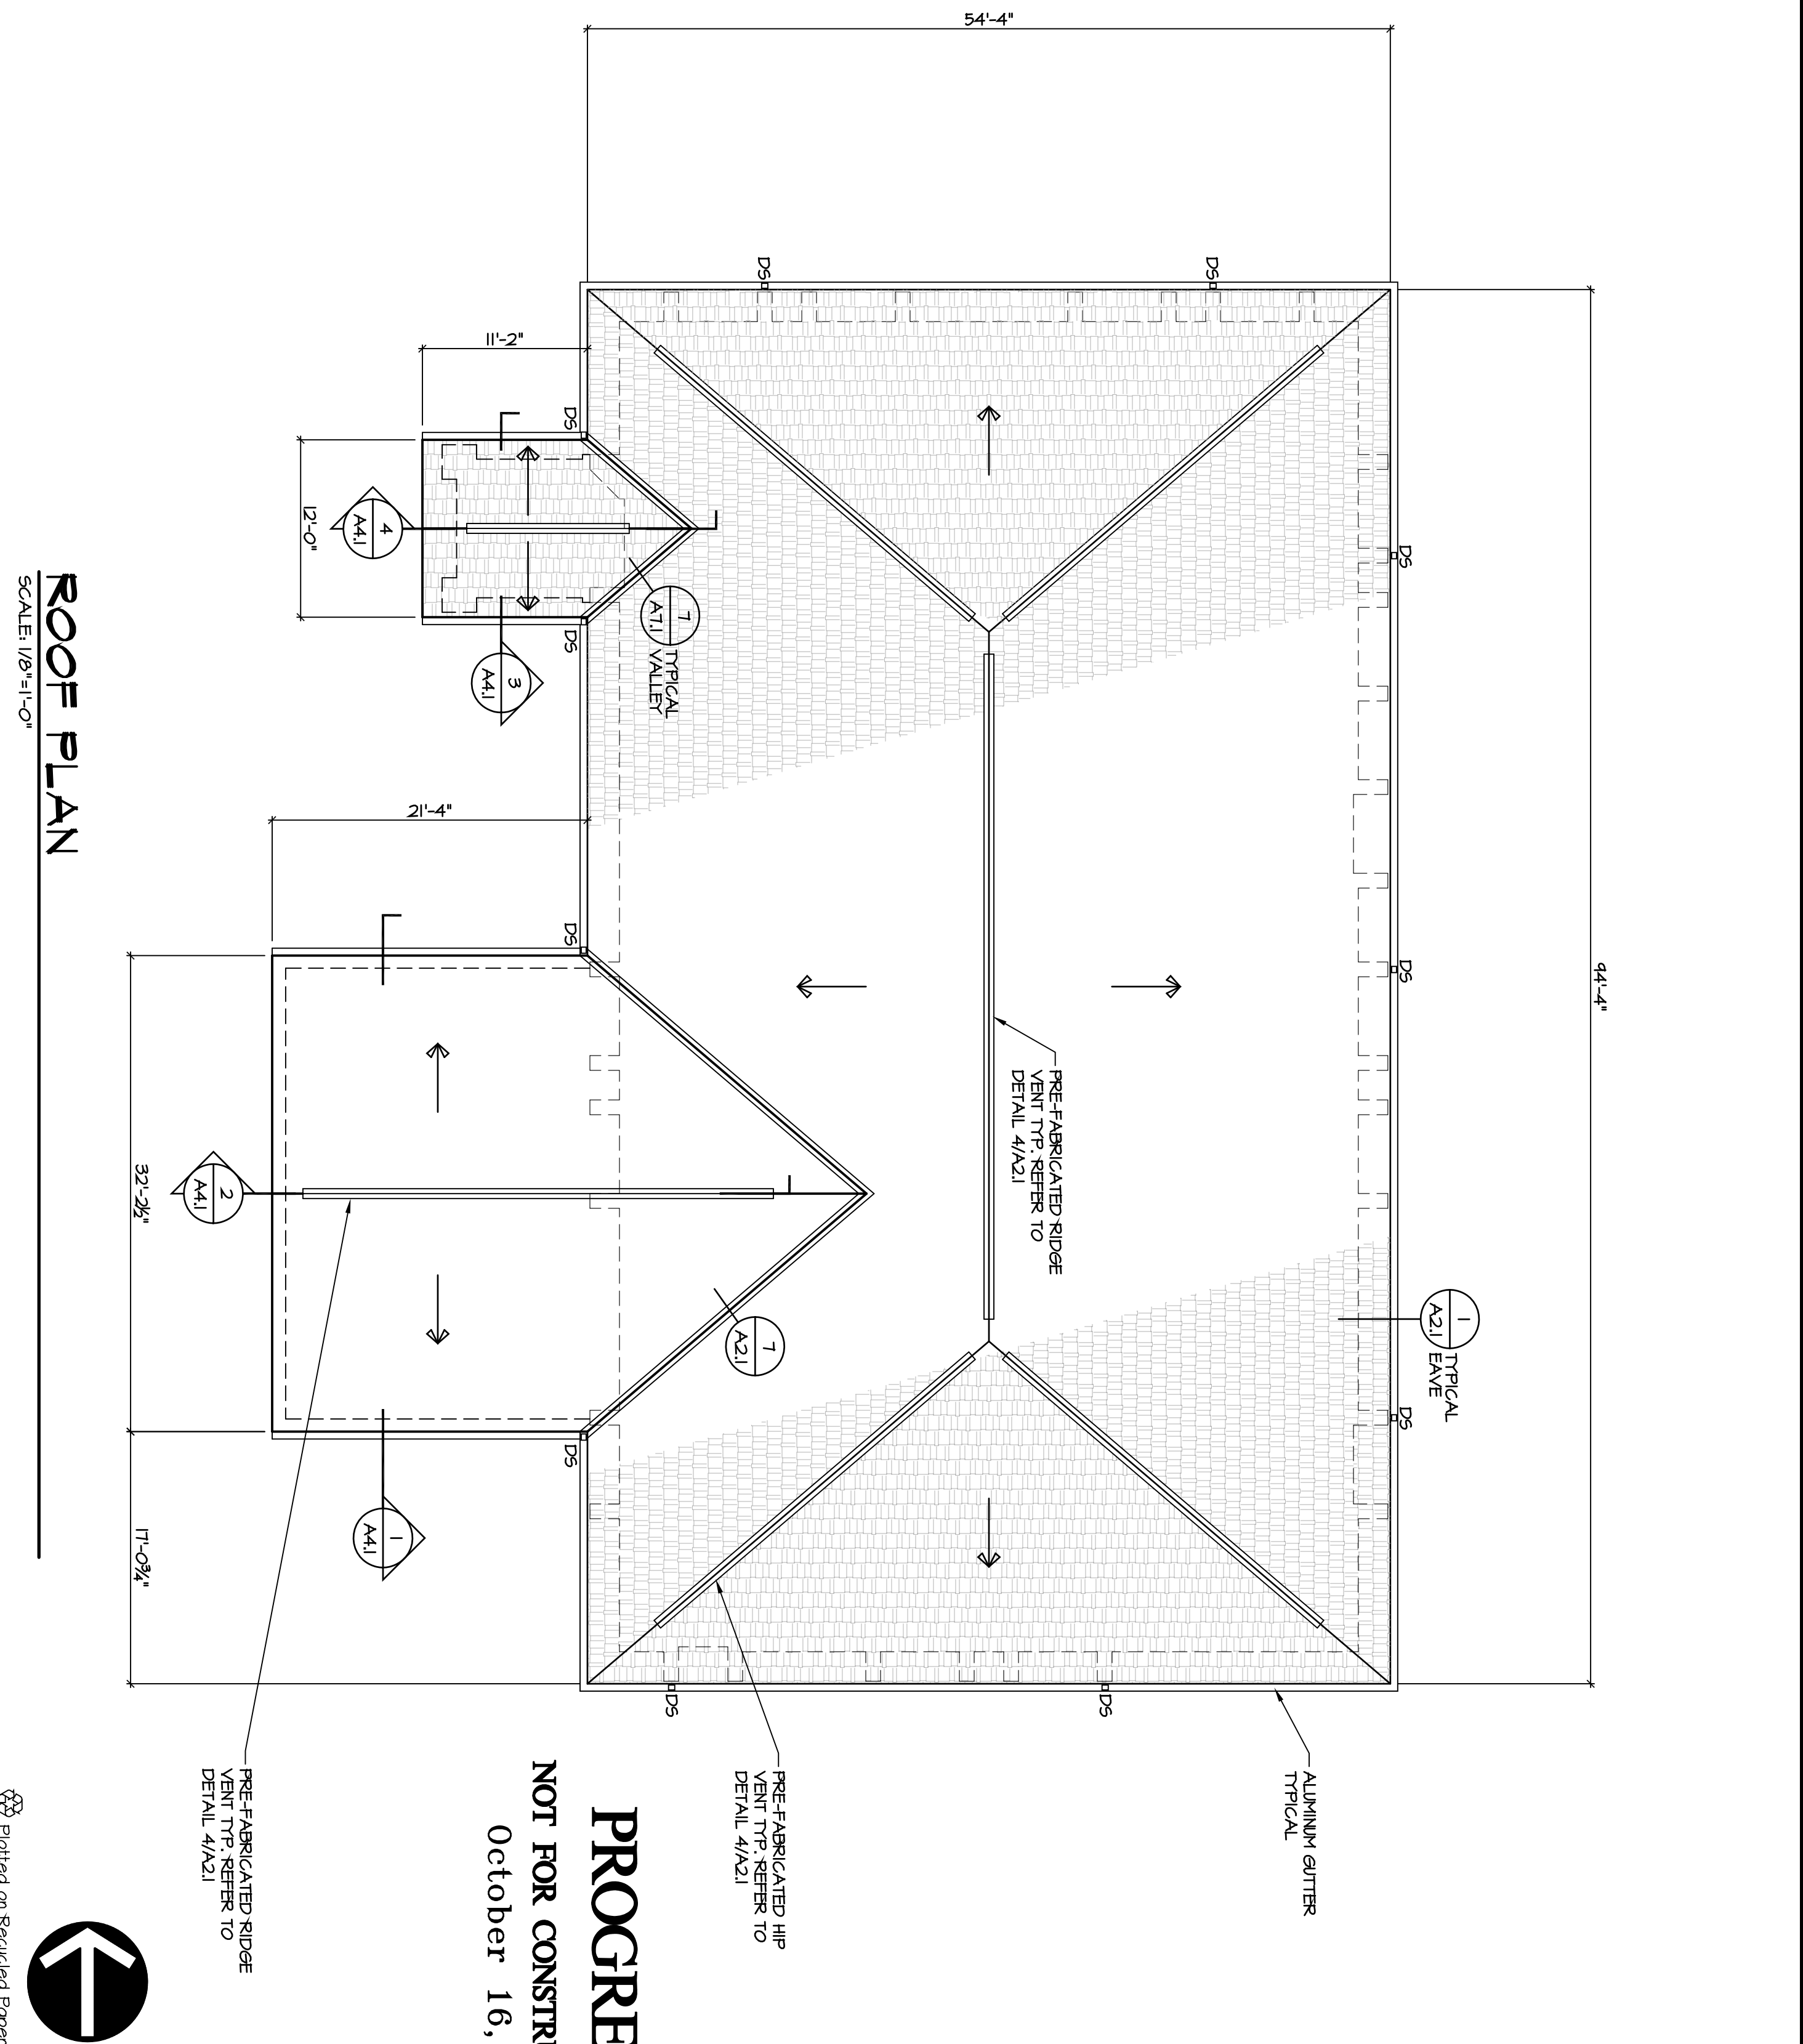

ROOF PLAN
SCALE 1/8"=1'-0"

PROGRESS
NOT FOR CONSTRUCTION
October 16, 2009

FRIAR ASSOCIATES INC.
281 Farmington Avenue
Farmington, CT 06032

SHEET NO. A2.1

PROJECT NUMBER 28141
ADDITIONS AND RENOVATIONS
CIGNA UNIVERSITY
1350 HALL BOULEVARD
BLOOMFIELD, CONNECTICUT

ROOF PLAN & DETAILS

REVISIONS

NO.	DATE	DESCRIPTION

DATE: 10-16-09
DRAWN BY: XXX
SCALE: XXX
REVIEWED BY: XXX
PROJECT NO. 28141
XXX

